


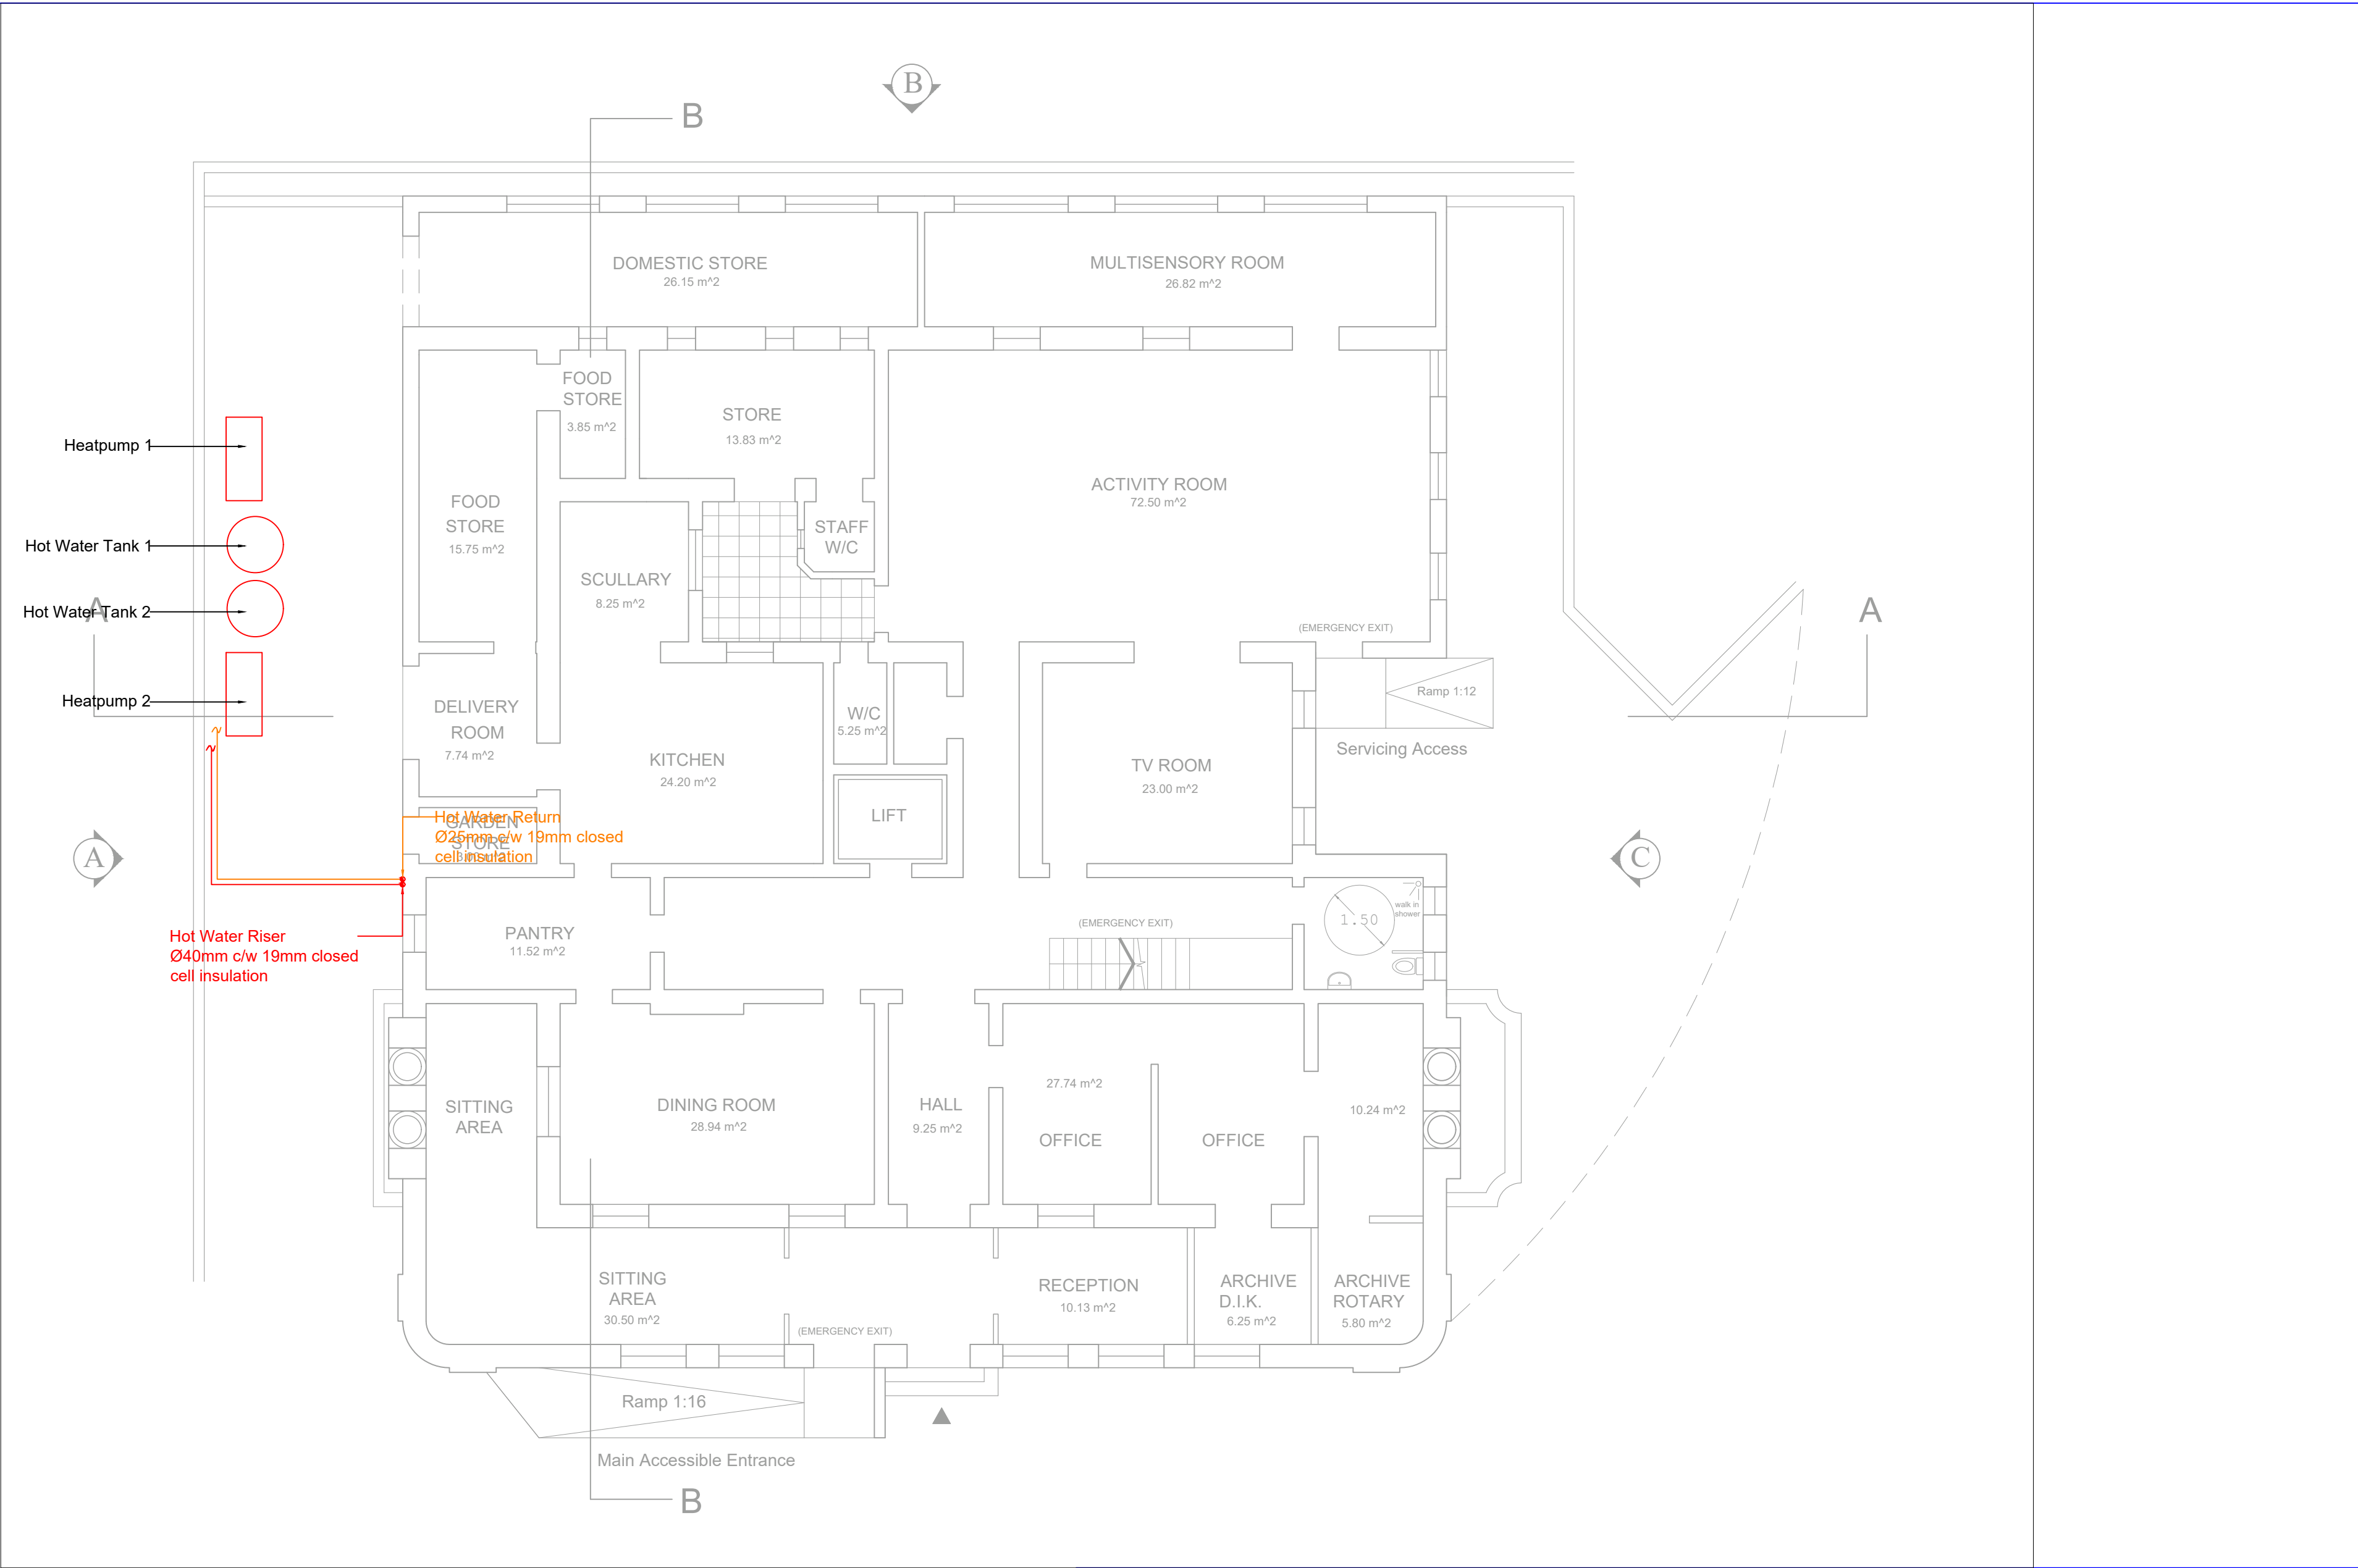

ECL CONSULTING ENGINEERS

202, TRIQ SAN BASTJAN, QORMI, QRM 2339, MALTA
T/F: +356 2733 4472 C: +356 9986 8828
W: WWW.ECLCE.COM E: INFO@ECLCE.COM

PROJECT:
DAR IL-KAPTAN


DRAWING TITLE:
GROUND FLOOR PLUMBING SYSTEM
LAYOUT

REVISION NO:	LAST UPDATED:	SCALE:	DRAWING NO:
01	17.02.26	1:100 (A2)	---

DESIGNED BY:	WARRANT NO:	CLIENT:
ING. J. ALDISIO	759	---


DRAWN BY:	DRAWING BY:
ING. J. ALDISIO	D.D

- This drawing remains property of ECL consulting engineers and must not be used or copied without written permission.
- Do not scale this drawing as a basis of measurement and the contractor is to check dimensions before construction. ECL consulting engineers must be informed about any contradiction or discrepancy before work is started. Any discrepancies arising from failure of doing so will be deemed to be the responsibility of contractor, and any claims for variation will be rejected.
- These drawings are conceptual to assist the tenderer to formulate a proposal for works. The successful tenderer is to provide his own construction drawings, to co-ordinate the installation with the building structure, finishes and all other M&E services.

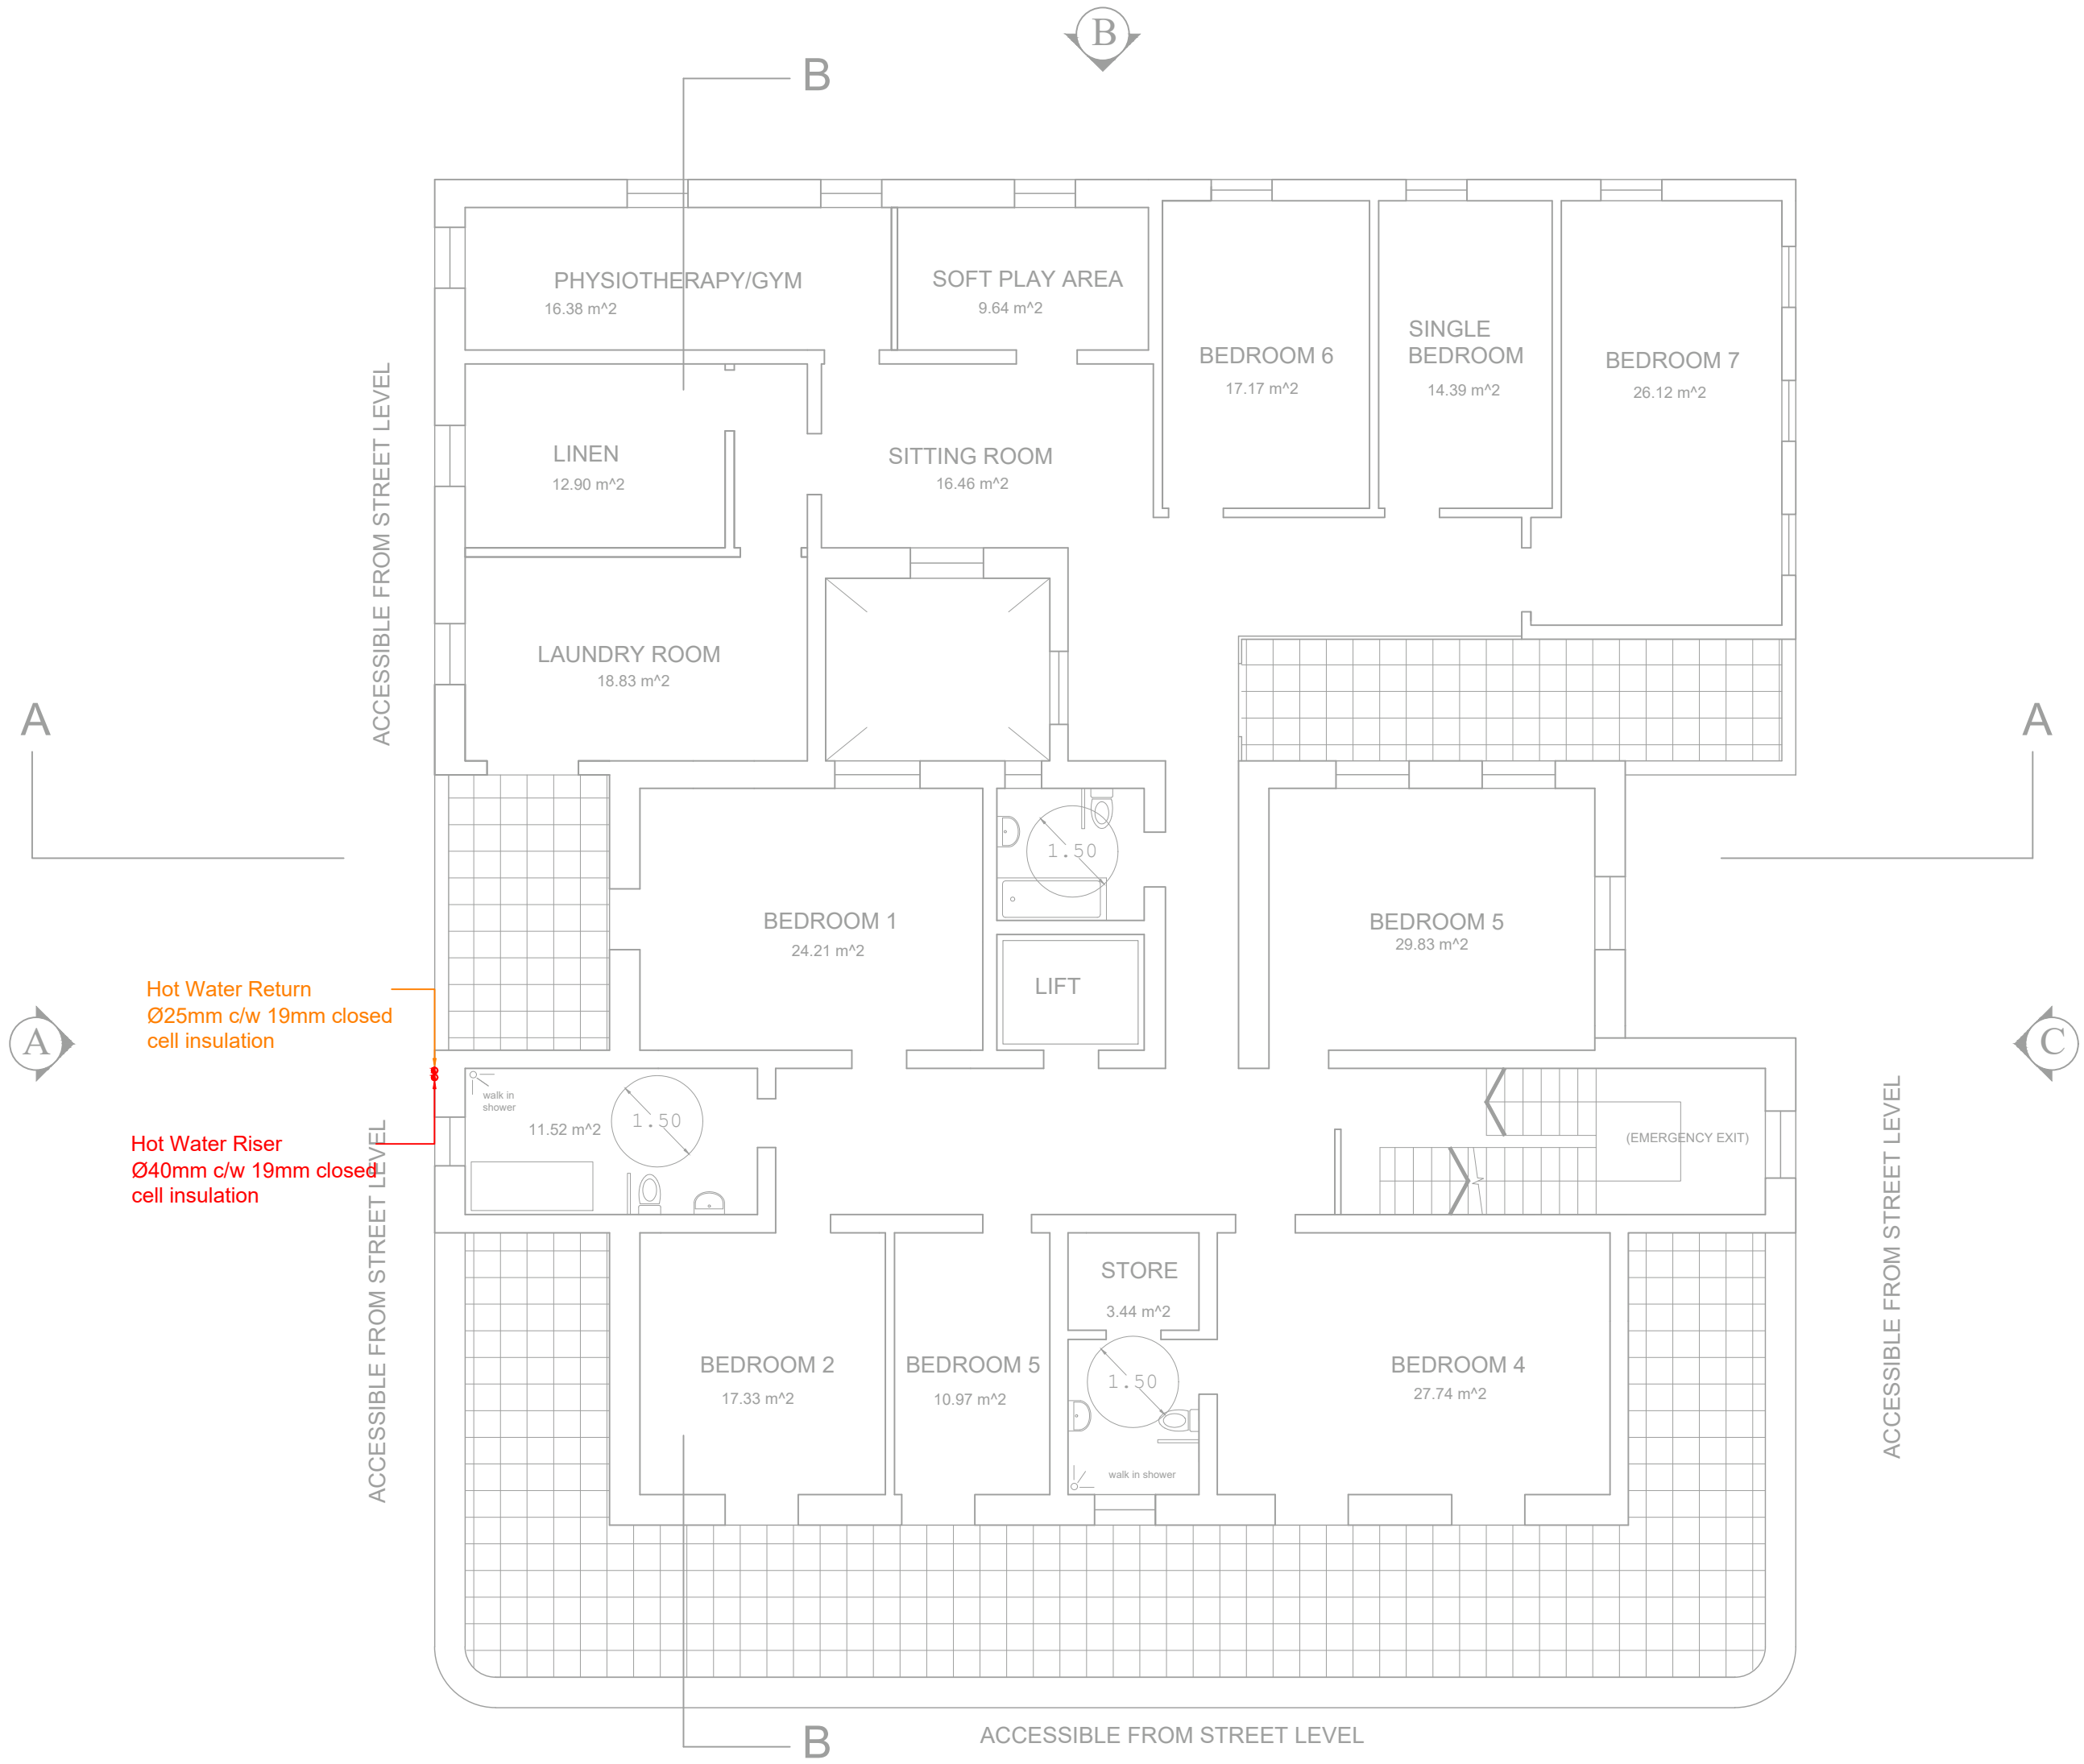

- This drawing remains property of ECL consulting engineers and must not be used or copied without written permission.
- Do not scale this drawing as a basis of measurement and the contractor is to check dimensions before construction. ECL consulting engineers must be informed about any contradiction or discrepancy before work is started. Any discrepancies arising from failure of doing so will be deemed to be the responsibility of contractor, and any claims for variation will be rejected.
- These drawings are conceptual to assist the tenderer to formulate a proposal for works. The successful tenderer is to provide his own construction drawings, to co-ordinate the installation with the building structure, finishes and all other M&E services.

ECL CONSULTING ENGINEERS			
202, TRIQ SAN BASTJAN, QORMI, QRM 2339, MALTA			
T/F: +356 2733 4472		C: +356 9986 8828	
W: WWW.ECLCE.COM		E: INFO@ECLCE.COM	
PROJECT:			
DAR IL-KAPTAN			
DRAWING TITLE:			
FIRST FLOOR PLUMBING LAYOUT			
REVISION NO:	LAST UPDATED:	SCALE:	DRAWING NO:
01	17.02.26	1:100 (A2)	—'—'—'
DESIGNED BY:		WARRANT NO:	CLIENT:
ING. J. ALDISIO		759	—
CHECKED BY:		DRAWN BY:	
ING. J. ALDISIO		D.D	

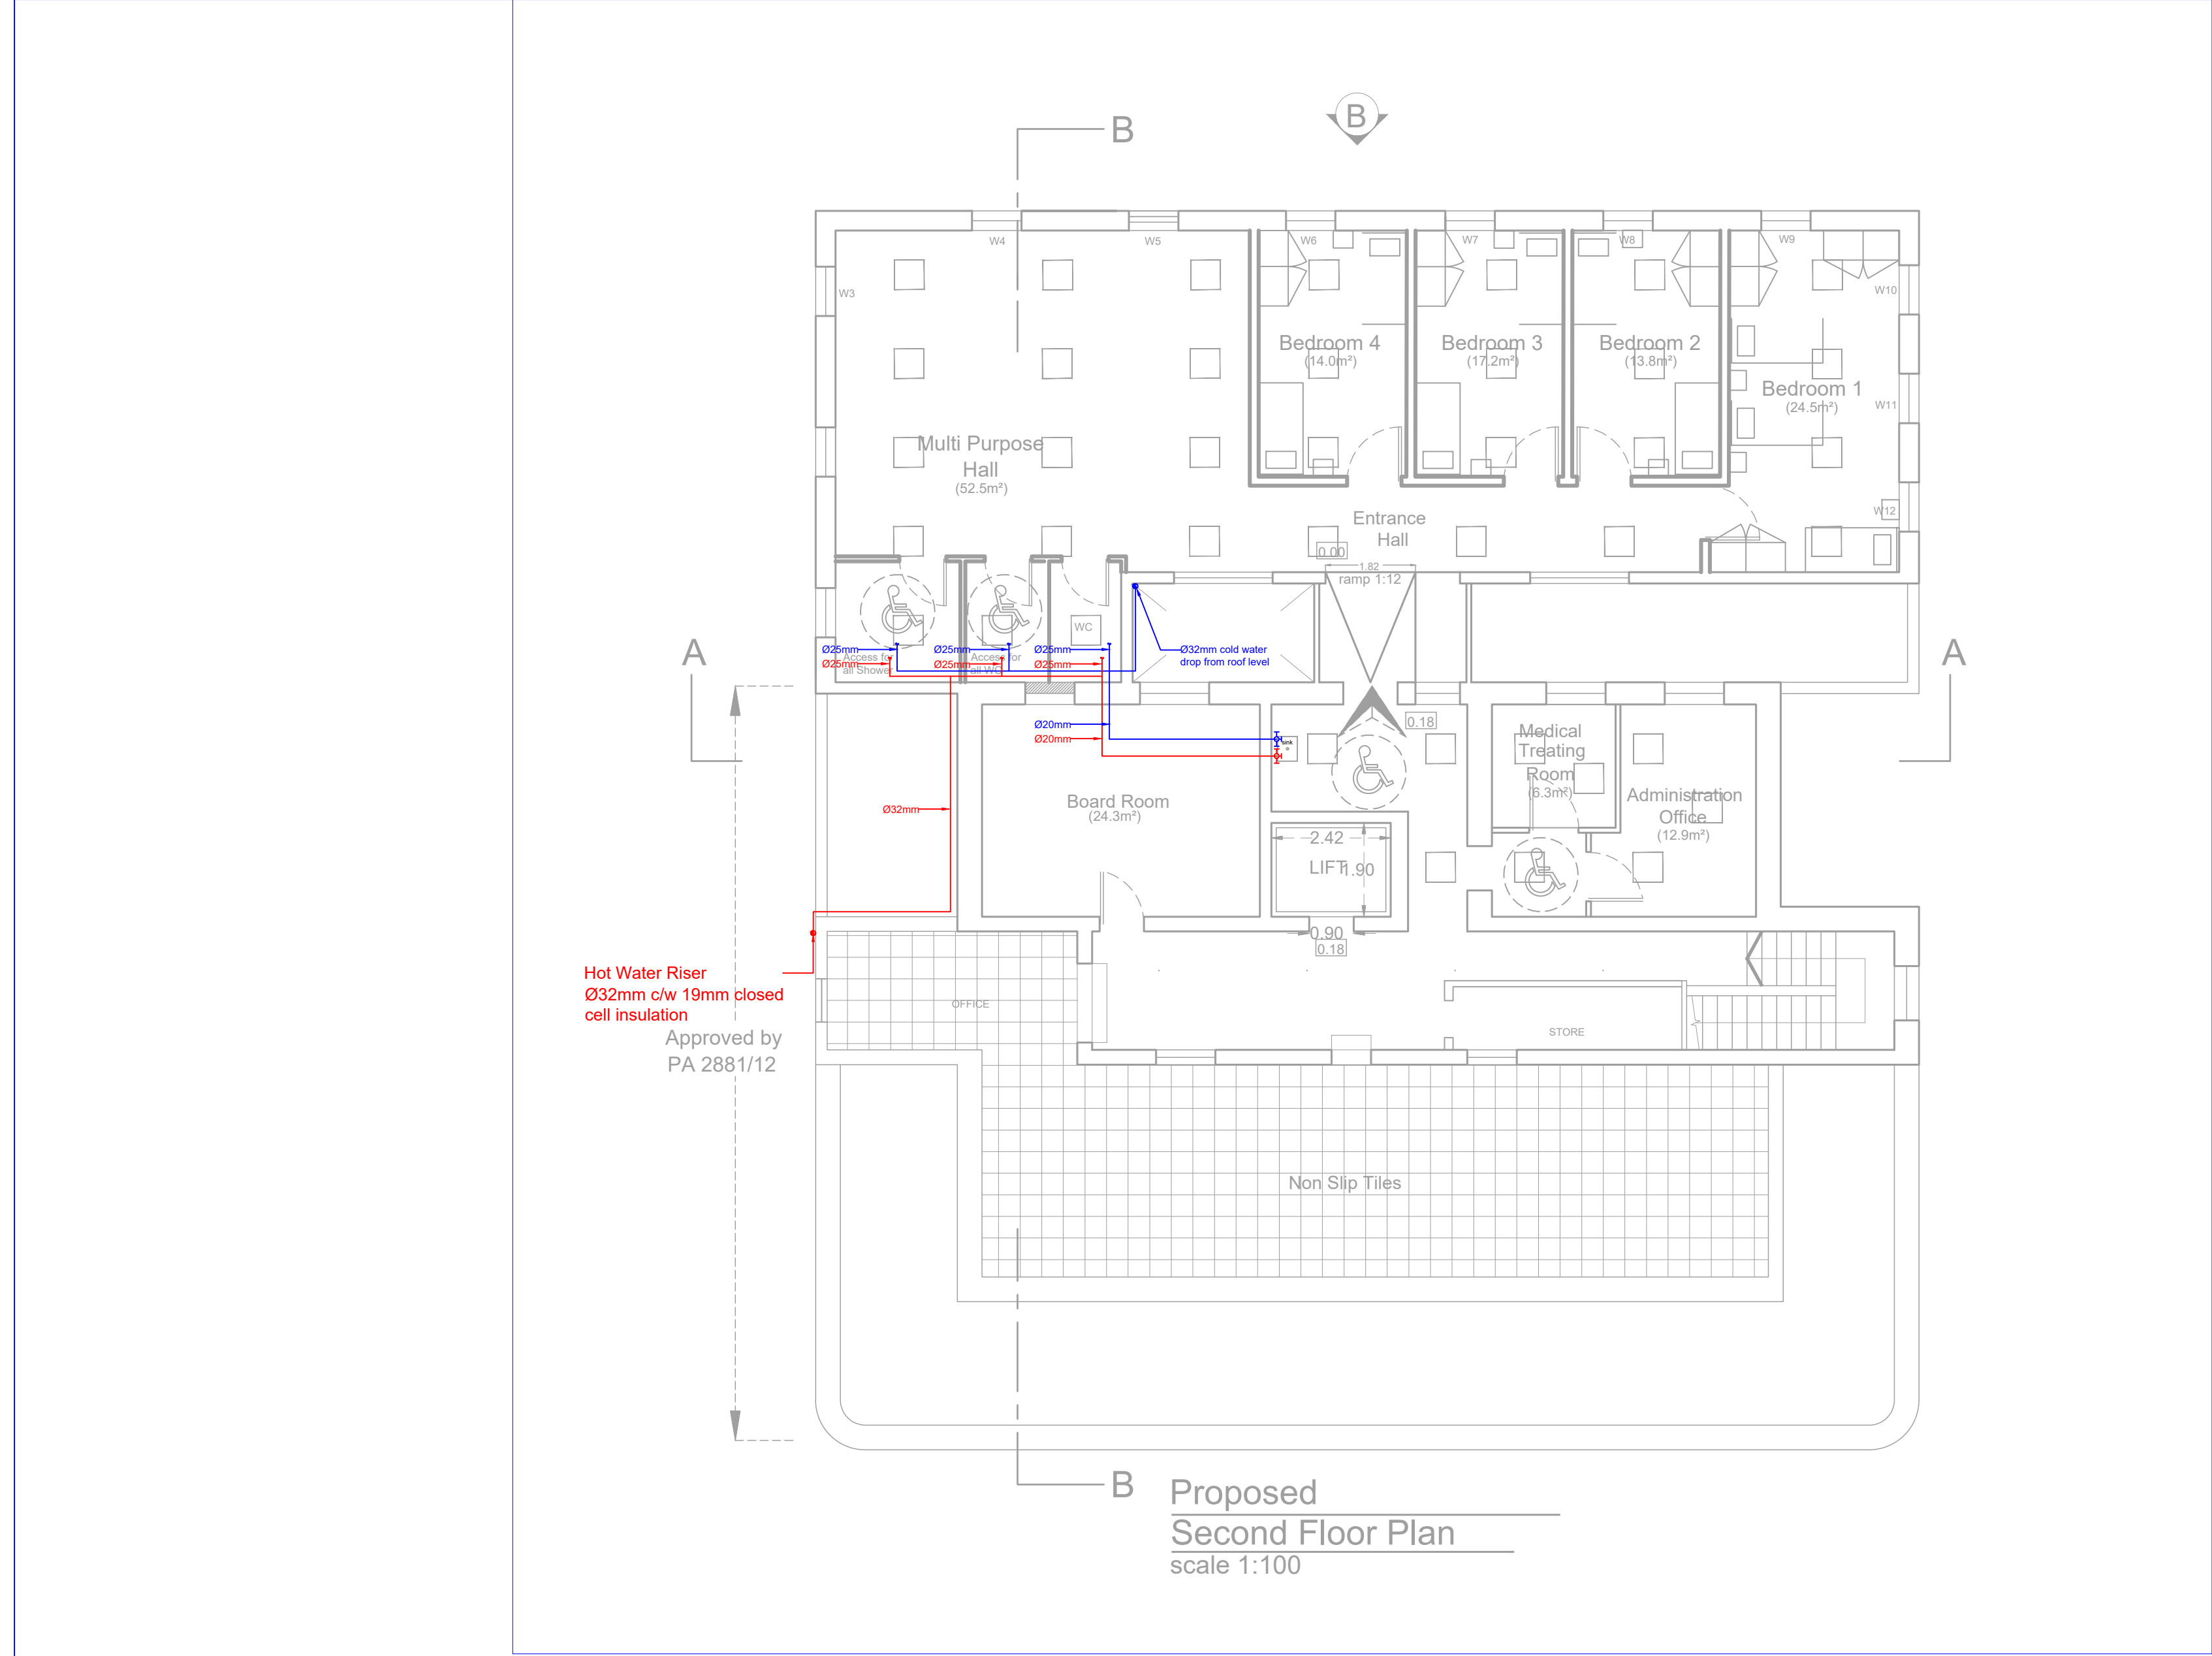

LEGEND:	PIPE SIZE (MMØ)
WASH HAND BASIN	20MMØ
SHOWER	25MMØ
BATH	25MMØ
TOILET	20MMØ

- This drawing remains property of ECL consulting engineers and must not be used or copied without written permission.
- Do not scale this drawing as a basis of measurement and the contractor is to check dimensions before construction. ECL consulting engineers must be informed about any contradiction or discrepancy before work is started. Any discrepancies arising from failure of doing so will be deemed to be the responsibility of contractor, and any claims for variation will be rejected.
- These drawings are conceptual to assist the tenderer to formulate a proposal for works. The successful tenderer is to provide his own construction drawings, to co-ordinate the installation with the building structure, finishes and all other M&E services.

ECL CONSULTING ENGINEERS

202, TRIQ SAN BASTJAN, QORMI, QRM 2339, MALTA
T/F: +356 2733 4472 C: +356 9986 8828
W: WWW.ECLCE.COM E: INFO@ECLCE.COM


PROJECT:
DAR IL-KAPTAN

DRAWING TITLE:
SECOND FLOOR PLUMBING LAYOUT

REVISION NO:	LAST UPDATED:	SCALE:	DRAWING NO:
01	17.02.26	1:100 (A2)	—

DESIGNED BY:	WARRANT NO:	CLIENT:
ING. J. ALDOISIO	759	—

DRAWN BY:	DRAWN BY:
ING. J. ALDOISIO	D.D

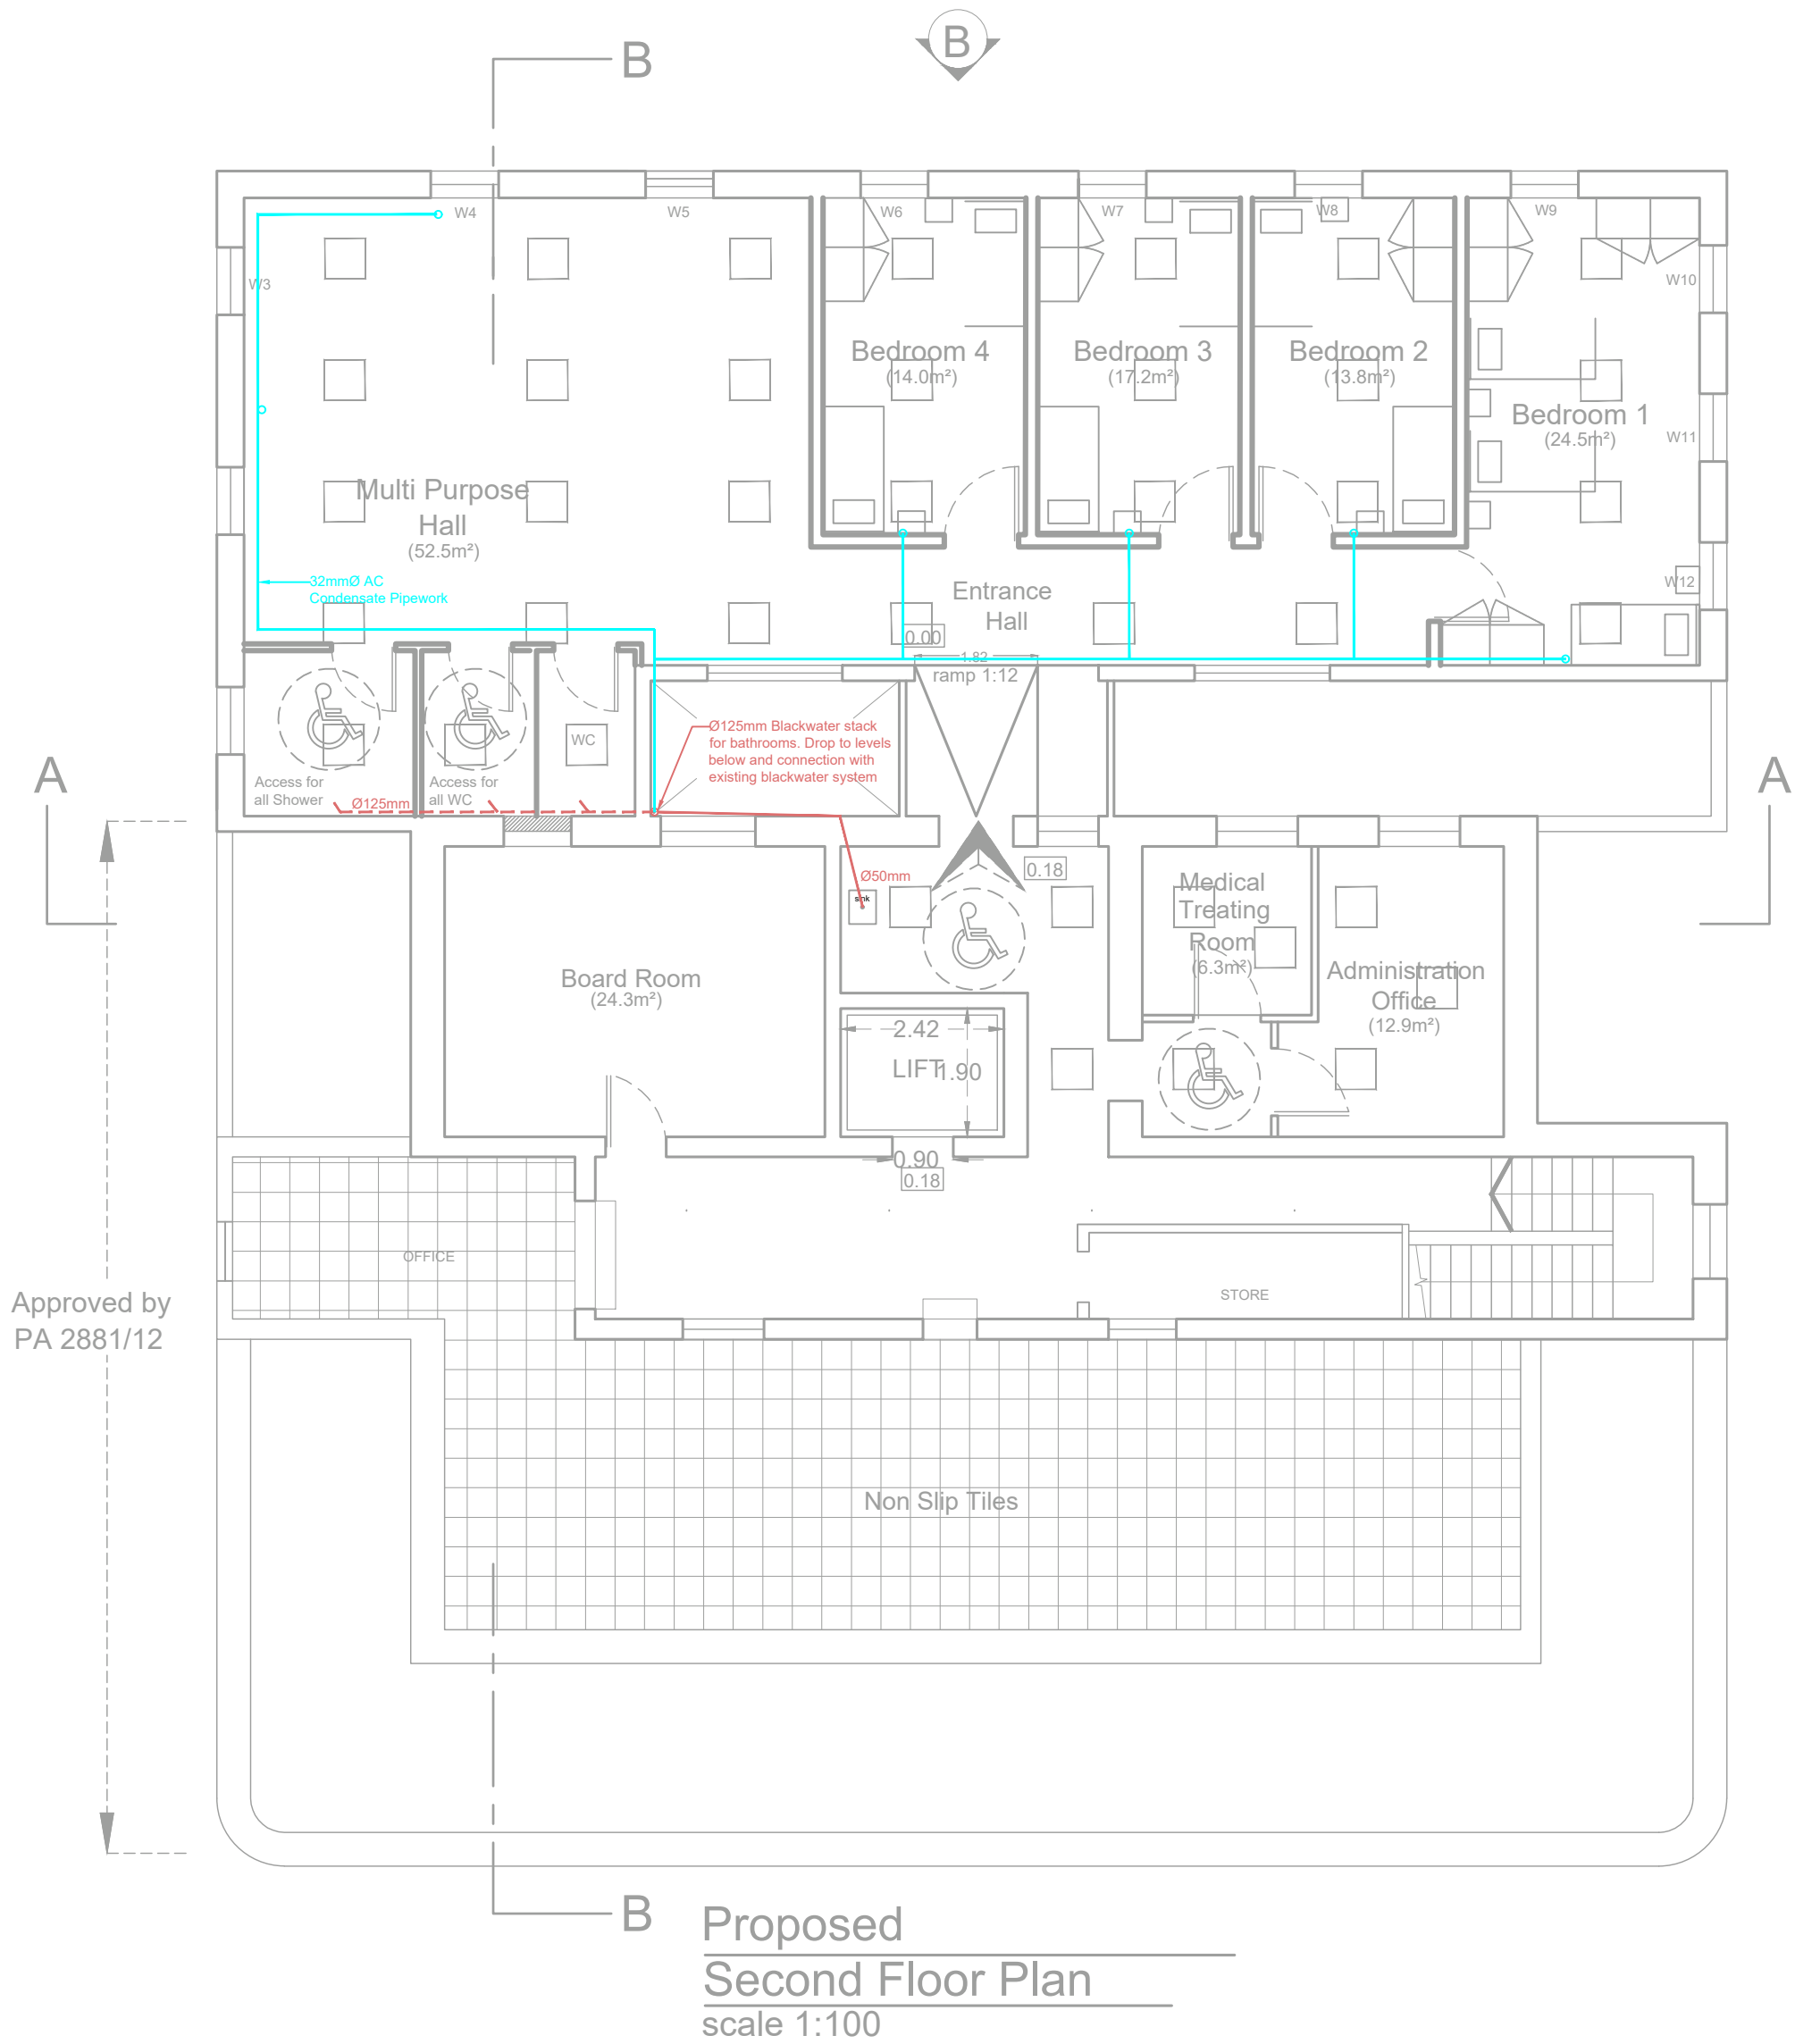

ECL CONSULTING ENGINEERS

202, TRIQ SAN BASTJAN, QORMI, QRM 2339, MALTA
T/F: +356 2733 4472 C: +356 9986 8828
W: WWW.ECLCE.COM E: INFO@ECLCE.COM

PROJECT:
DAR IL-KAPTAN


DRAWING TITLE:
SECOND FLOOR BLACKWATER LAYOUT

REVISION NO:	LAST UPDATED:	SCALE:	DRAWING NO:
01	17.02.26	1:100 (A2)	—

DESIGNED BY:	WARRANT NO:	CLIENT:
ING. J. ALDISIO	759	—

DRAWN BY:	DRAWING BY:
ING. J. ALDISIO	D.D

- This drawing remains property of ECL consulting engineers and must not be used or copied without written permission.
- Do not scale this drawing as a basis of measurement and the contractor is to check dimensions before construction. ECL consulting engineers must be informed about any contradiction or discrepancy before work is started. Any discrepancies arising from failure of doing so will be deemed to be the responsibility of contractor, and any claims for variation will be rejected.
- These drawings are conceptual to assist the tenderer to formulate a proposal for works. The successful tenderer is to provide his own construction drawings, to co-ordinate the installation with the building structure, finishes and all other M&E services.

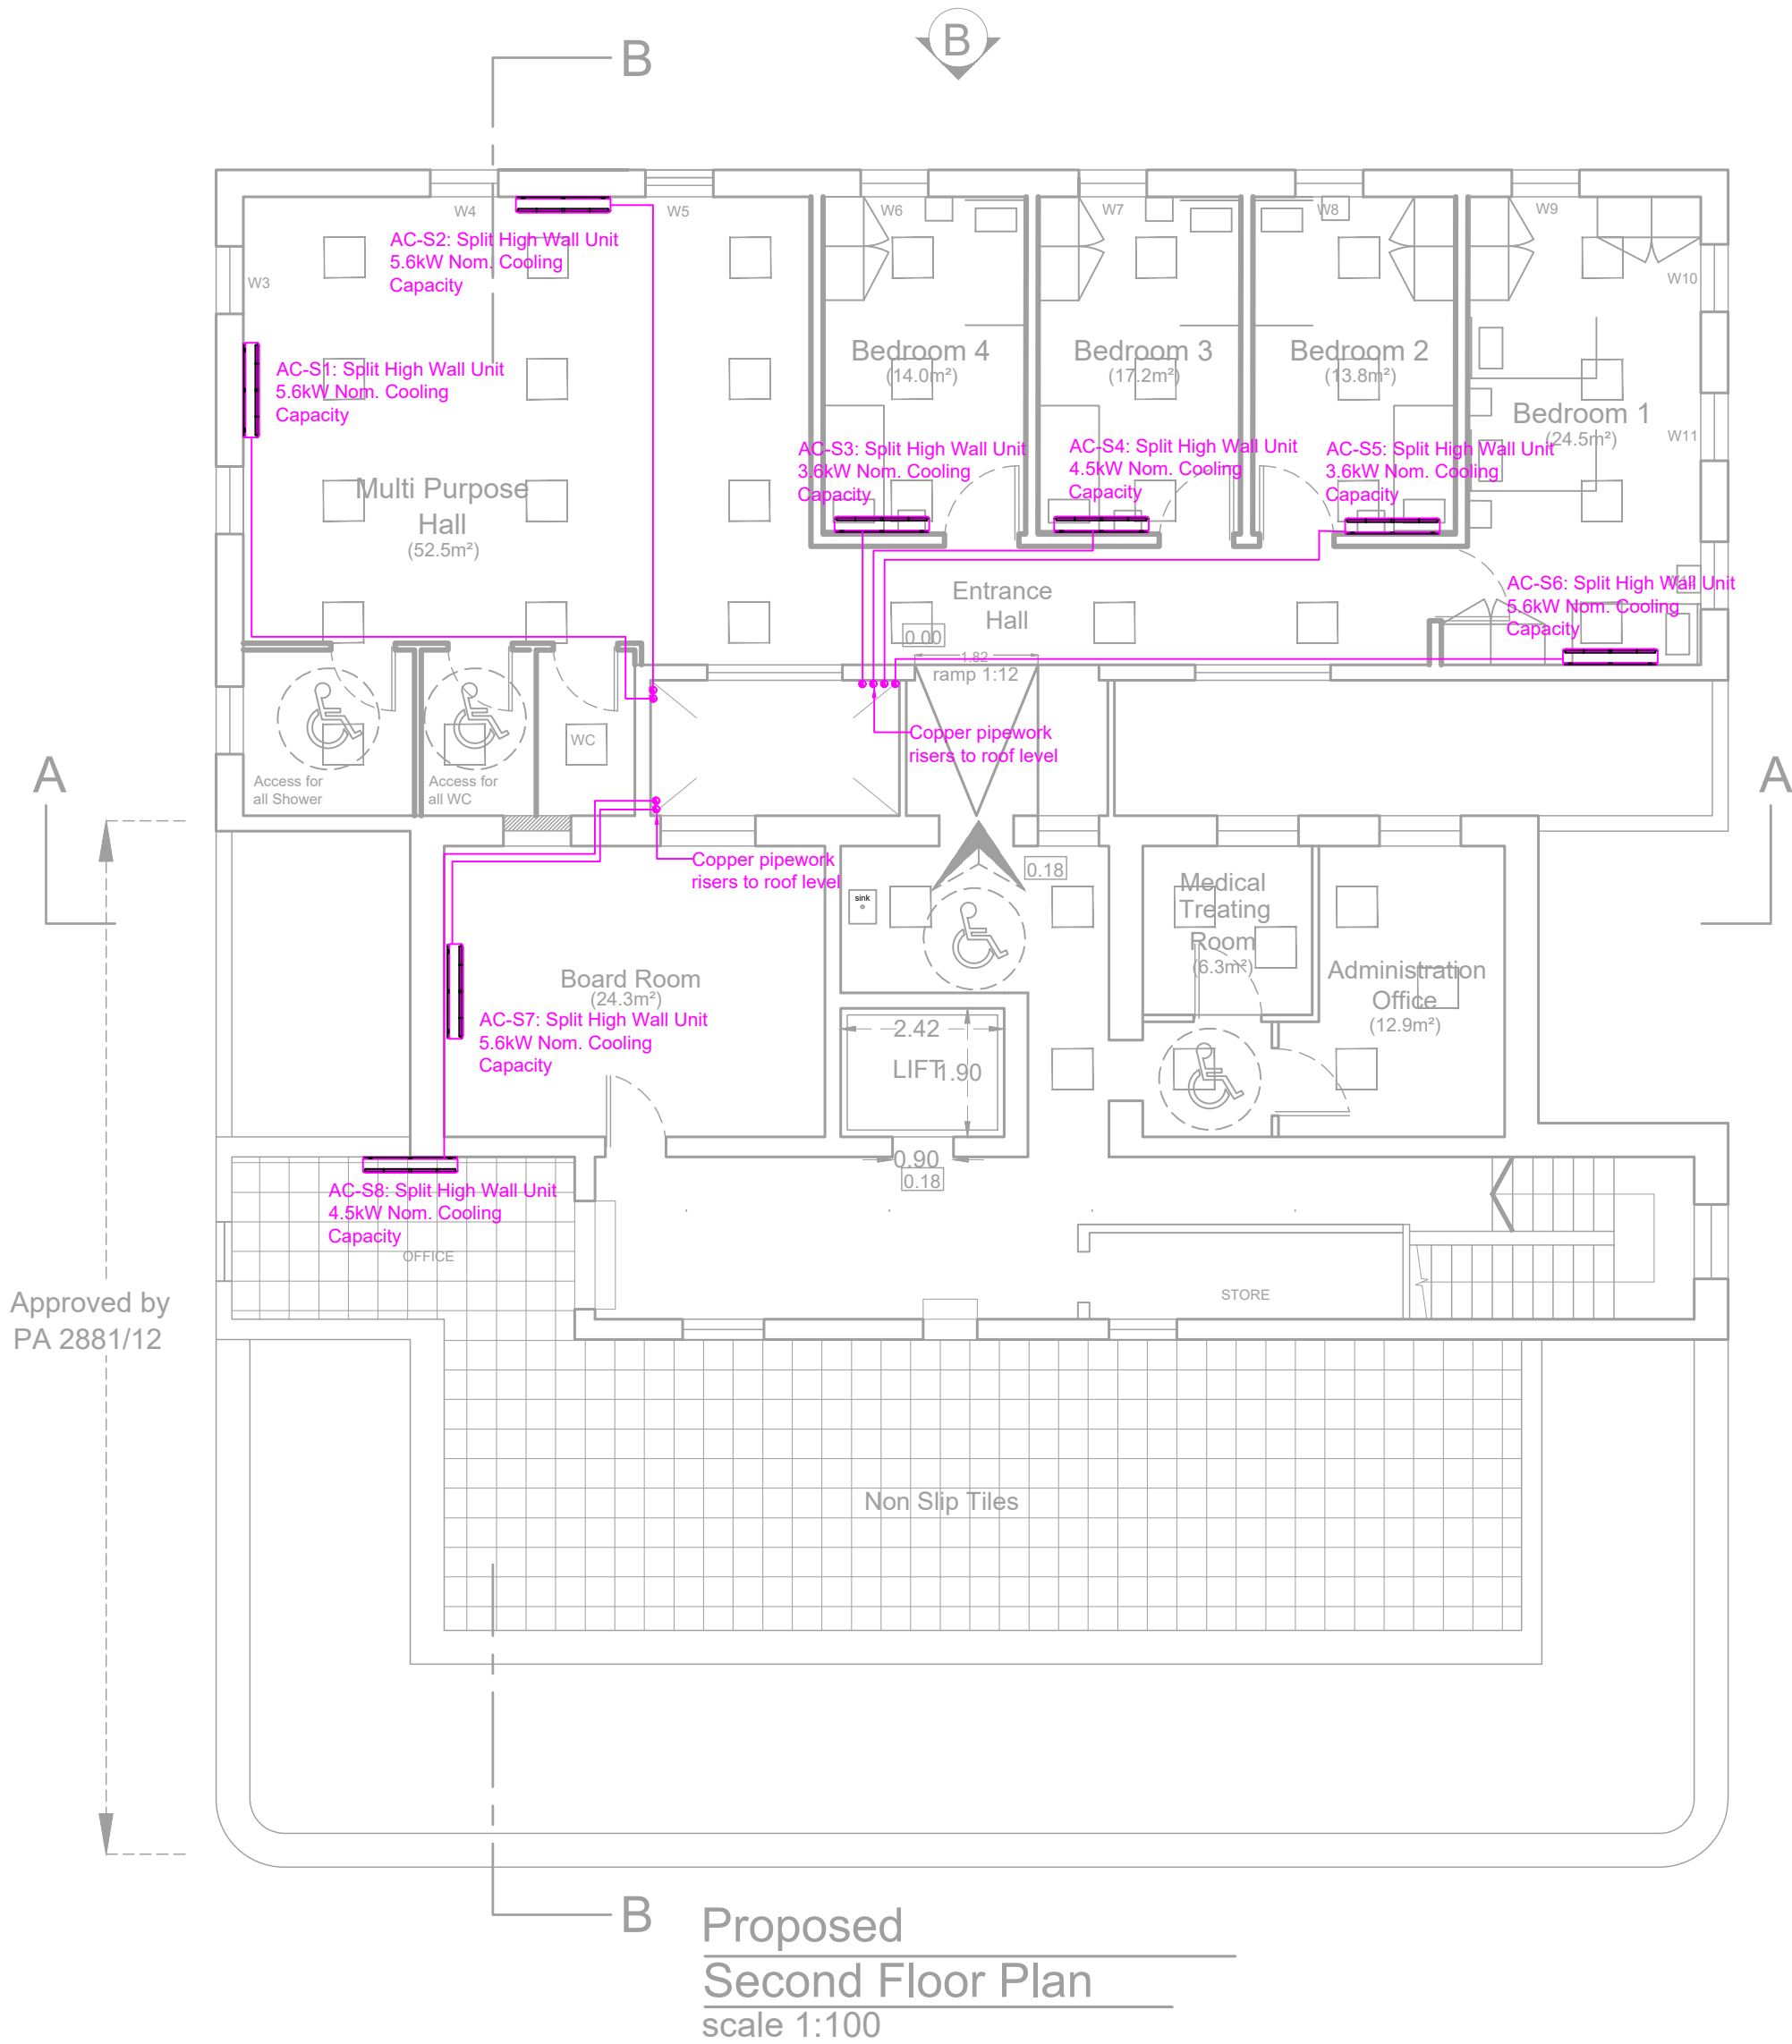

ECL CONSULTING ENGINEERS

202, TRIQ SAN BASTJAN, QORMI, QRM 2339, MALTA
T/F: +356 2733 4472 C: +356 9986 8828
W: WWW.ECLCE.COM E: INFO@ECLCE.COM

PROJECT:
DAR IL-KAPTAN


DRAWING TITLE:
SECOND FLOOR AIR CONDITIONING LAYOUT

REVISION NO:	LAST UPDATED:	SCALE:	DRAWING NO:
01	17.02.26	1:100 (A2)	—

DESIGNED BY:	WARRANT NO:	CLIENT:
ING. J. ALDOISIO	759	—

DRAWN BY:	DRAWING BY:
ING. J. ALDOISIO	D.D

- This drawing remains property of ECL consulting engineers and must not be used or copied without written permission.
- Do not scale this drawing as a basis of measurement and the contractor is to check dimensions before construction. ECL consulting engineers must be informed about any contradiction or discrepancy before work is started. Any discrepancies arising from failure of doing so will be deemed to be the responsibility of contractor, and any claims for variation will be rejected.
- These drawings are conceptual to assist the tenderer to formulate a proposal for works. The successful tenderer is to provide his own construction drawings, to co-ordinate the installation with the building structure, finishes and all other M&E services.

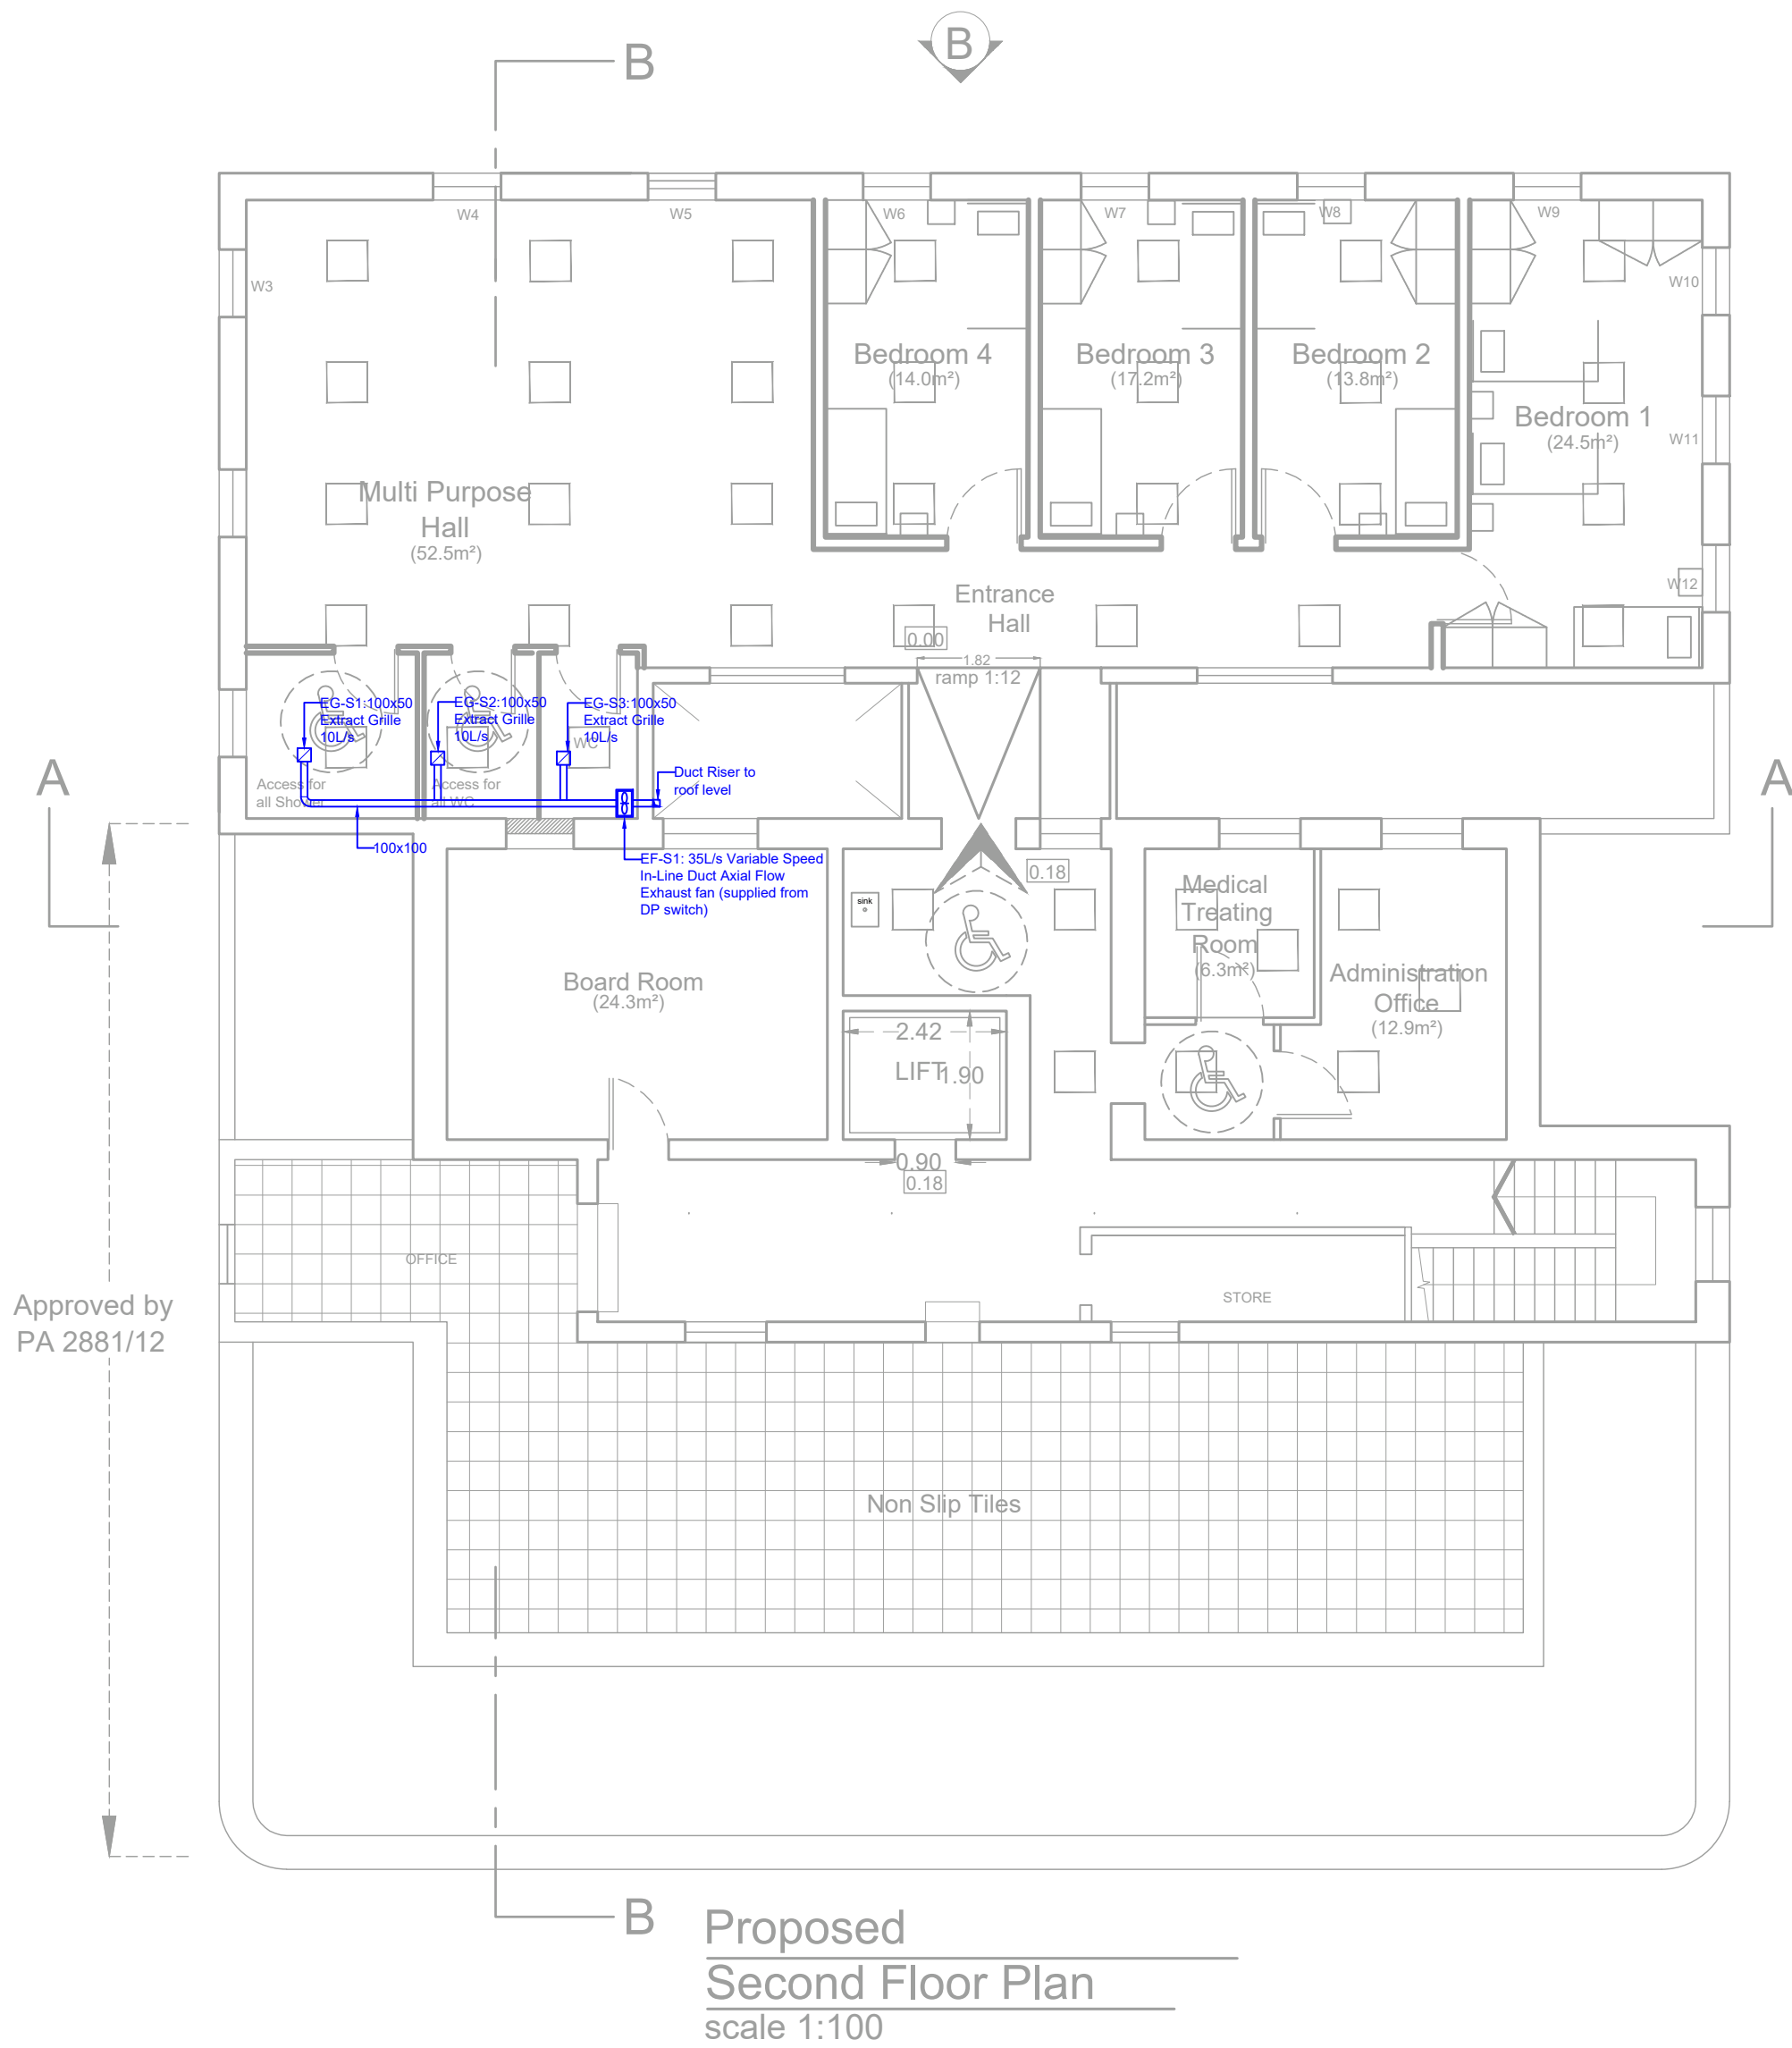

ECL CONSULTING ENGINEERS

202, TRIQ SAN BASTJAN, QORMI, QRM 2339, MALTA
T/F: +356 2733 4472 C: +356 9986 8828
W: WWW.ECLCE.COM E: INFO@ECLCE.COM

PROJECT:
DAR IL-KAPTAN


DRAWING TITLE:
SECOND FLOOR SANITARY AREAS
VENTILATION LAYOUT

REVISION NO:	LAST UPDATED:	SCALE:	DRAWING NO:
01	17.02.26	1:100 (A2)	—

DESIGNED BY:	WARRANT NO:	CLIENT:
ING. J. ALDISIO	759	—

DRAWN BY:	DRAWN BY:
ING. J. ALDISIO	D.D

- This drawing remains property of ECL consulting engineers and must not be used or copied without written permission.
- Do not scale this drawing as a basis of measurement and the contractor is to check dimensions before construction. ECL consulting engineers must be informed about any contradiction or discrepancy before work is started. Any discrepancies arising from failure of doing so will be deemed to be the responsibility of contractor, and any claims for variation will be rejected.
- These drawings are conceptual to assist the tenderer to formulate a proposal for works. The successful tenderer is to provide his own construction drawings, to co-ordinate the installation with the building structure, finishes and all other M&E services.

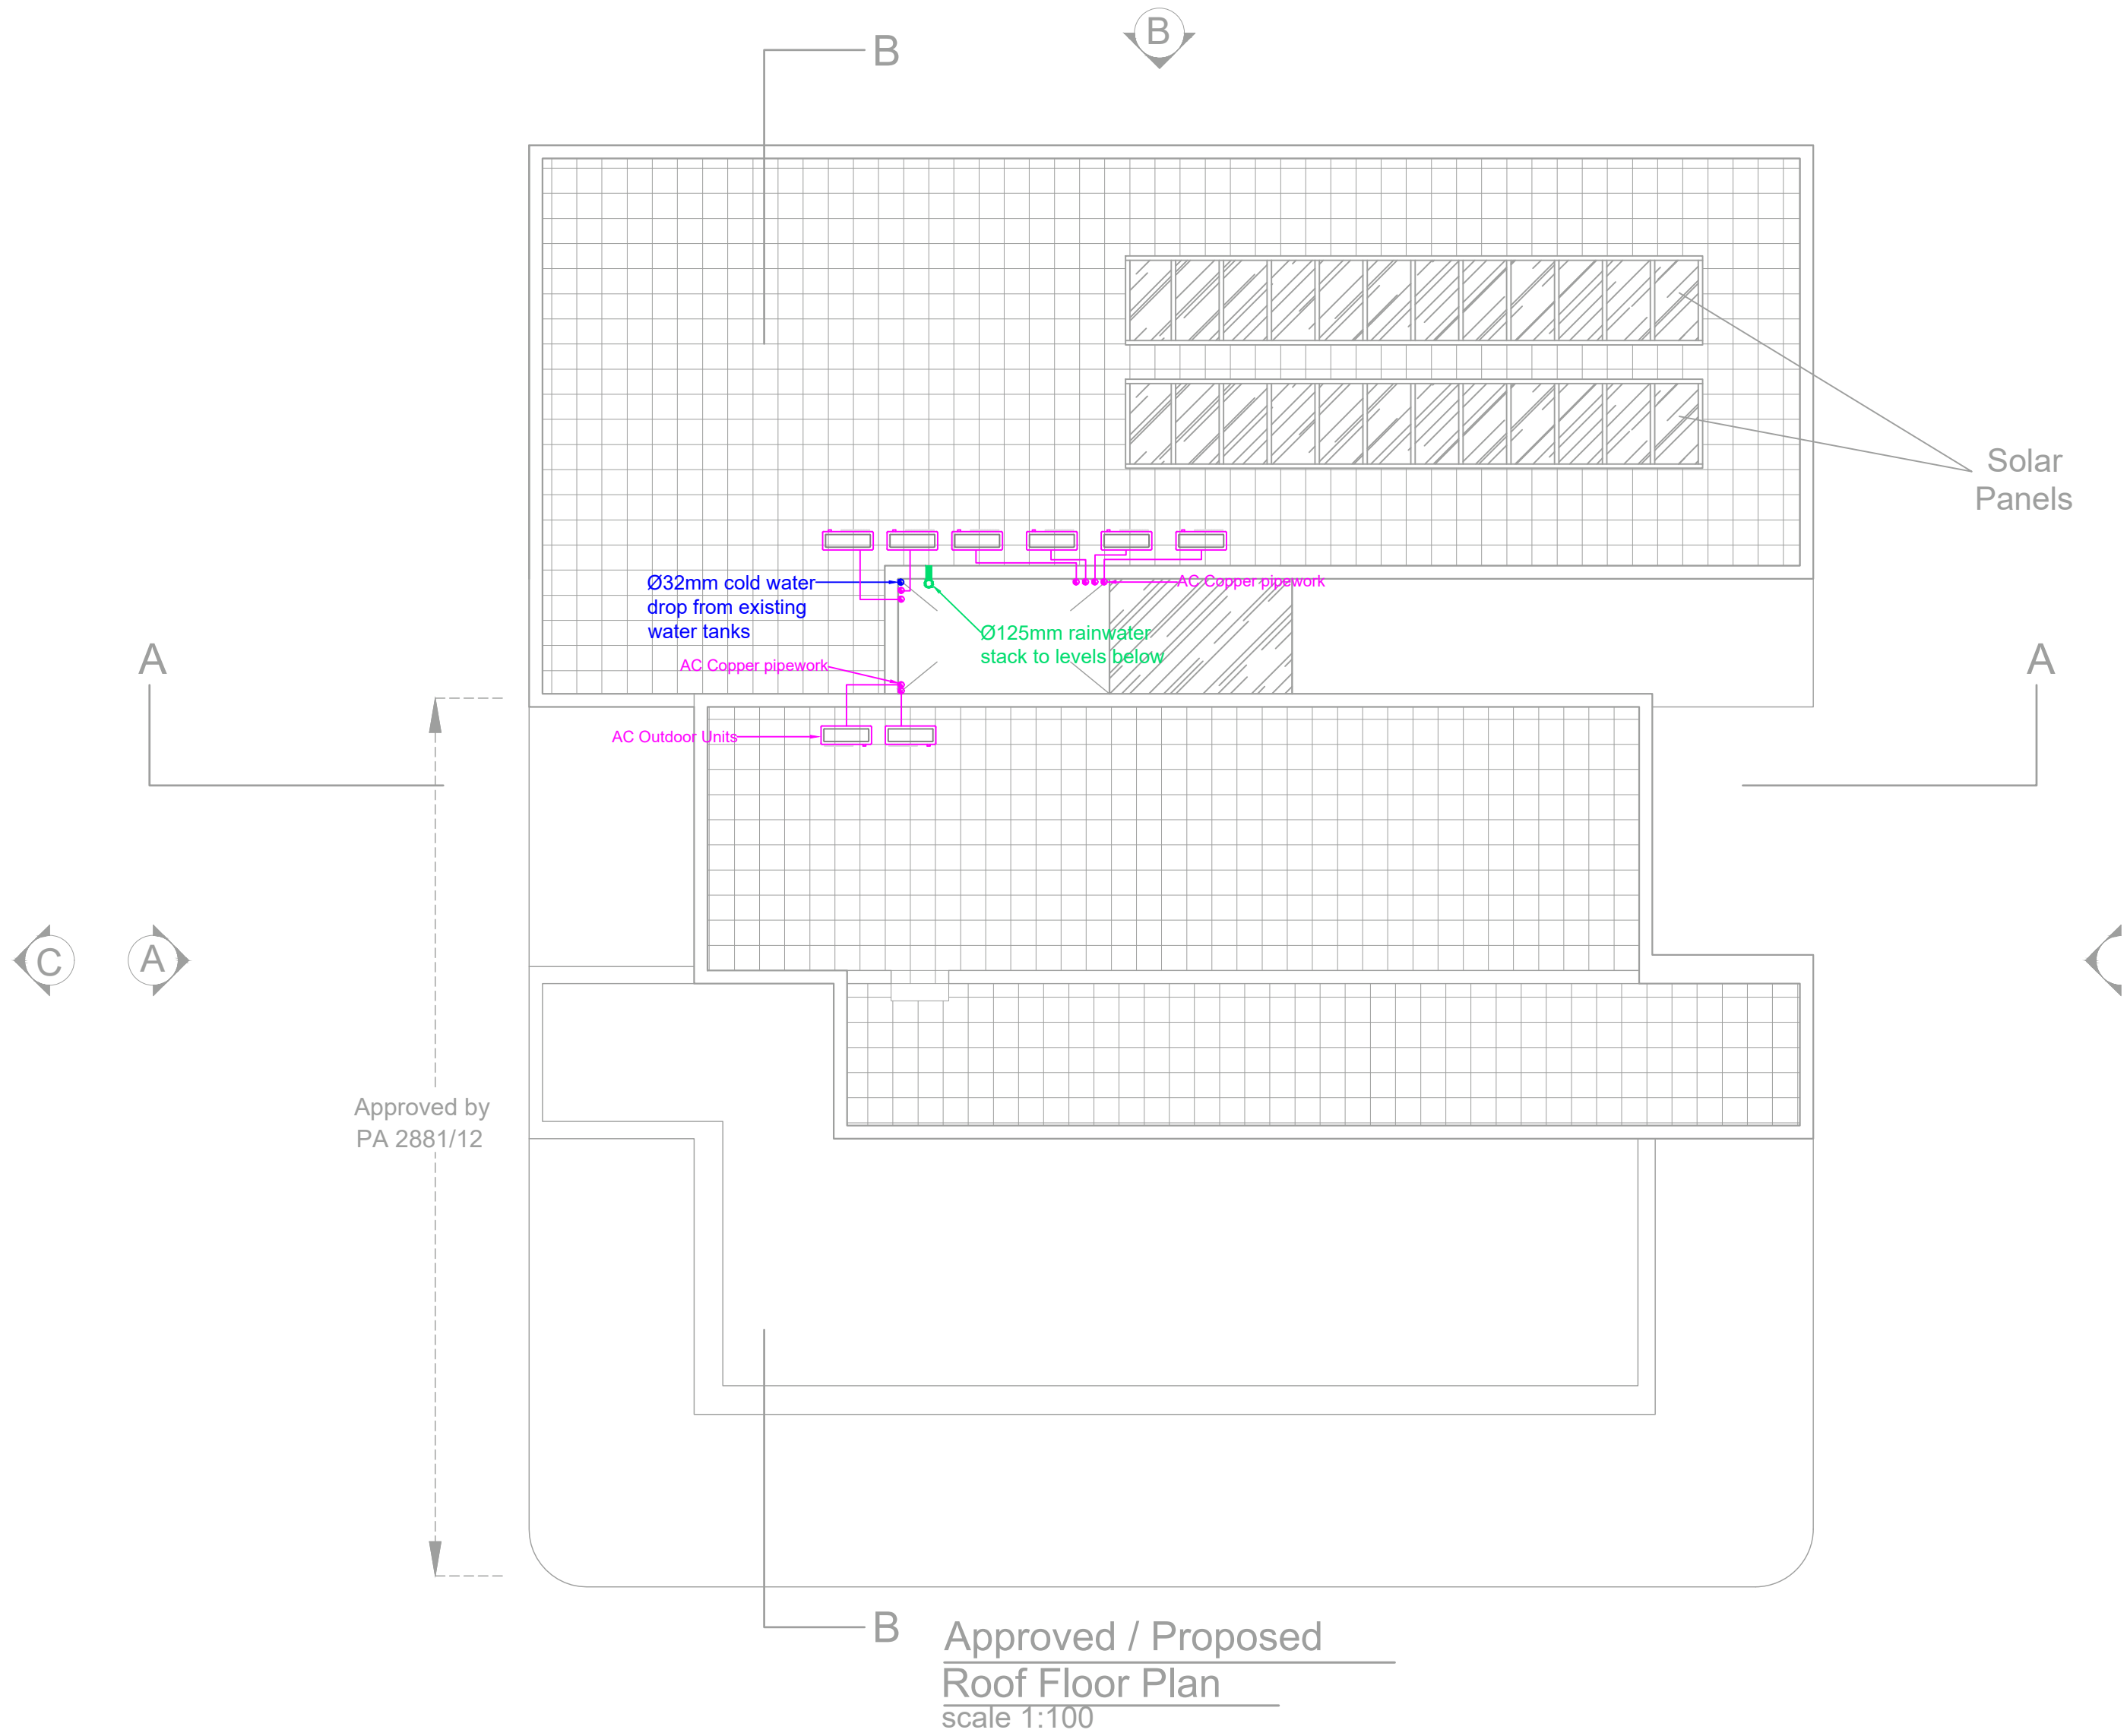

LEGEND				ECL CONSULTING ENGINEERS
O VERTICAL STACK				
				202, TRIQ SAN BASTJAN, QORMI, QRM 2339, MALTA
				T/F: +356 2733 4472 C: +356 9986 8828 W: WWW.ECLCE.COM E: INFO@ECLCE.COM
				PROJECT: DAR IL-KAPTAN
				DRAWING TITLE: ROOF LAYOUT
REVISION NO: 01		LAST UPDATED: 17.02.26	SCALE: 1:100 (A2)	DRAWING NO: ____
DESIGNED BY: ING. J. ALOISIO			WARRANT NO: 759	CLIENT: ____
CHECKED BY: ING. J. ALOISIO			DRAWN BY: D.D	
1. This drawing remains property of ECL consulting engineers and must not be used or copied without written permission.				
2. Do not scale this drawing as a basis of measurement and the contractor is to check dimensions before construction. ECL consulting engineers must be informed about any contradiction or discrepancy before work is started. Any discrepancies arising from failure of doing so will be deemed to be the responsibility of contractor, and any claims for variation will be rejected.				
3. These drawings are conceptual to assist the tenderer to formulate a proposal for works. The successful tenderer is to provide his own construction drawings, to co-ordinate the installation with the building structure, finishes and all other M&E services.				